


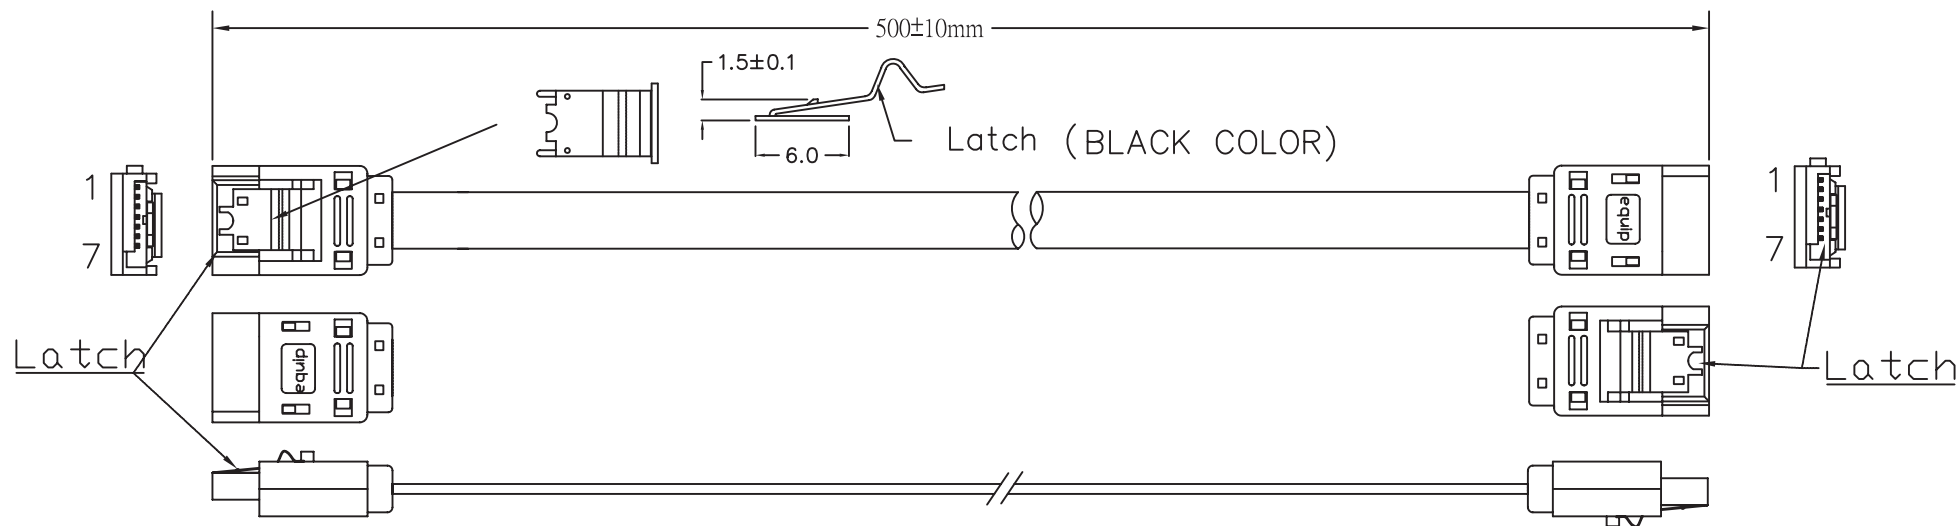

SERIAL ATA 7P(WITH Latch)  
(ASS'Y BLACK COLOR)

SERIAL ATA 7P (WITH Latch)  
(ASS'Y BLACK COLOR)

NOTE:

1. CABLE: 26AWG,UL2725,AL-FOIL,(26AWG\*2C+AL)\*2C+4D(28AWG),OD=2.3\*8.3mm, RED COLOR(Pantone 200C),PVC JACKET.
2. LENGTH: 500mm.
3. CONNECTORS: SERIAL ATA 7P\*2PCS(BLACK INSULATION,With metal Latch).
4. MOLD: ASSEMBLING TYPE(180°)--TYPE(180°)
5. CONTACTS:  

|               |       |   |   |   |   |
|---------------|-------|---|---|---|---|
| SERIAL ATA 7P | 1+4+7 | 2 | 3 | 5 | 6 |
| SERIAL ATA 7P | 1+4+7 | 2 | 3 | 5 | 6 |
6. OPEN/SHORT TEST: 100% TEST.  
INSULATION: MIN. 2M.
7. PACKING: E'pui ZIP BAG

| ITEM NO | Color | Length    |
|---------|-------|-----------|
| 111900  | Red   | 500±10mm  |
| 111901  | Red   | 1000±20mm |

|          |      |             |             |  |    |   |                                                                                       |          |                                                                                       |  |
|----------|------|-------------|-------------|--|----|---|---------------------------------------------------------------------------------------|----------|---------------------------------------------------------------------------------------|--|
| COMPANY  | DDC  |             | ITEM NO.    |  | NO | B |  | SCALE    | NON                                                                                   |  |
| REVISION | DATE | DISCRIPTION | DRAWN BY    |  |    |   |                                                                                       | UNIT<mm> |  |  |
|          |      |             | DESIGNED BY |  |    |   |                                                                                       |          |                                                                                       |  |
|          |      |             | APPROVAL BY |  |    |   |                                                                                       |          |                                                                                       |  |
|          |      |             |             |  |    |   |                                                                                       |          |                                                                                       |  |