


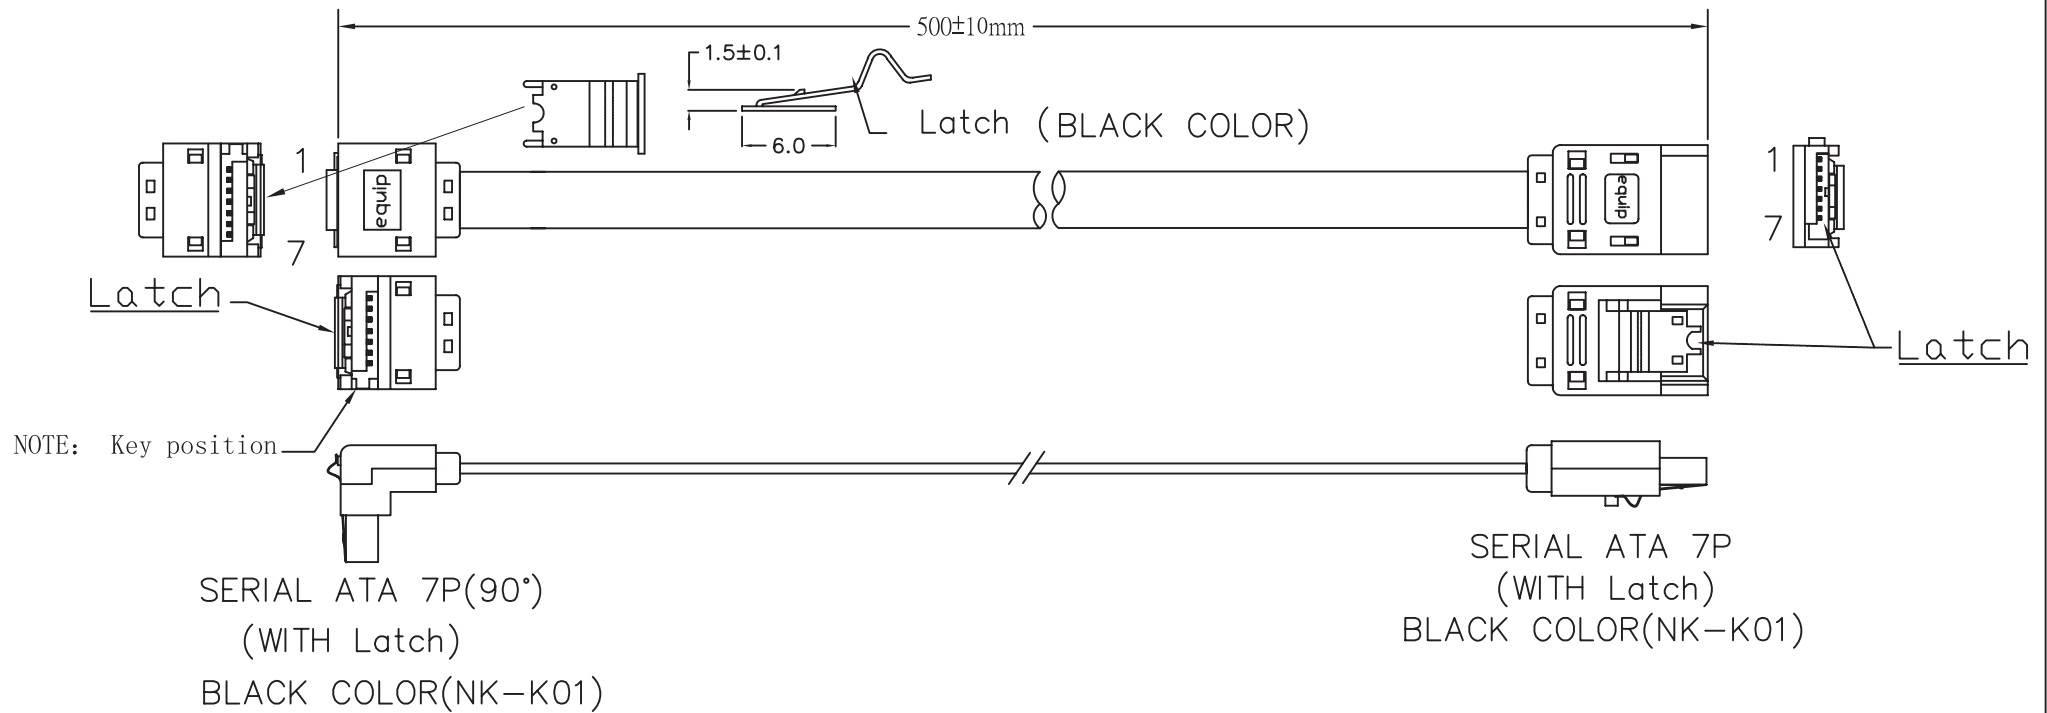

NOTE:

1. CABLE: 26AWG,UL2725,AL-FOIL,(26AWG*2C+AL)*2C+4D(28AWG),RED COLOR(Pantone 200C),
OD=2.3*8.3mm,PVC JACKET.
2. LENGTH: 0.5M.
3. CONNECTORS: SERIAL ATA 7P*2PCS(BLACK INSULATION,With metal Latch).
4. MOLD: ASSEMBLING TYPE(90°)--TYPE(180°)
5. CONTACTS:

SERIAL ATA 7P	1+4+7	2	3	5	6
SERIAL ATA 7P	1+4+7	2	3	5	6
6. OPEN/SHORT TEST: 100% TEST.
INSULATION: MIN. 2M.
7. PACKING: E'puip ZIP BAG

ITEM NO	Color	Length
111902	Red	500±10mm
111903	Red	1000±20mm

COMPANY	DDC		ITEM NO.		NO	B		SCALE	NON	
REVISION	DATE	DISCRIPTION	DRAWN BY					UNIT<mm>		
			DESIGNED BY					DRAWING NO.		
			APPROVAL BY							